





12/31/2015 5:35:21 PM - C:\IP\200-12748-15003\CAD\SHEETFILES\HYD-PROF.DWG - TEITSM, MARC

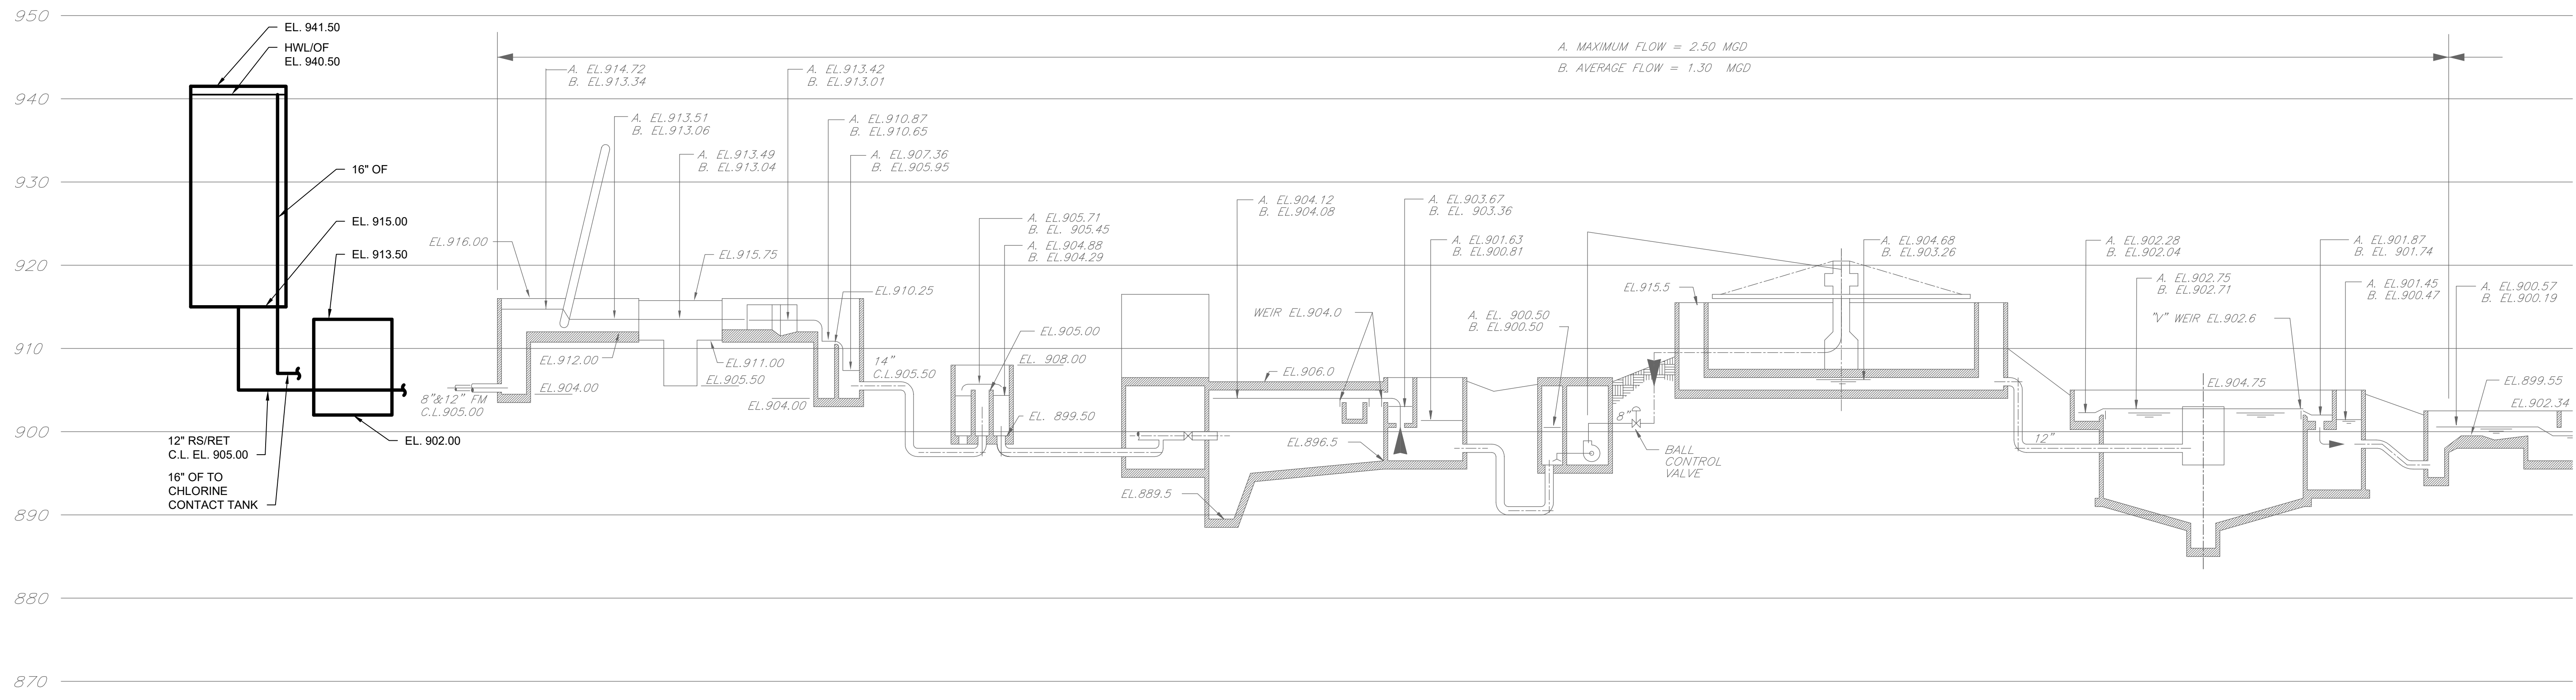


WET WEATHER STORAGE TANK    VALVE AND METER VAULT    SCREEN    GRIT TANK    PARSHALL FLUME    INFLUENT FLOW SPLIT STRUCTURE    PRIMARY SETTLING TANKS NO. 1 THRU NO. 4    PRIMARY EFFLUENT PUMPS    TRICKLING FILTER    INTERMEDIATE SETTLING TANK

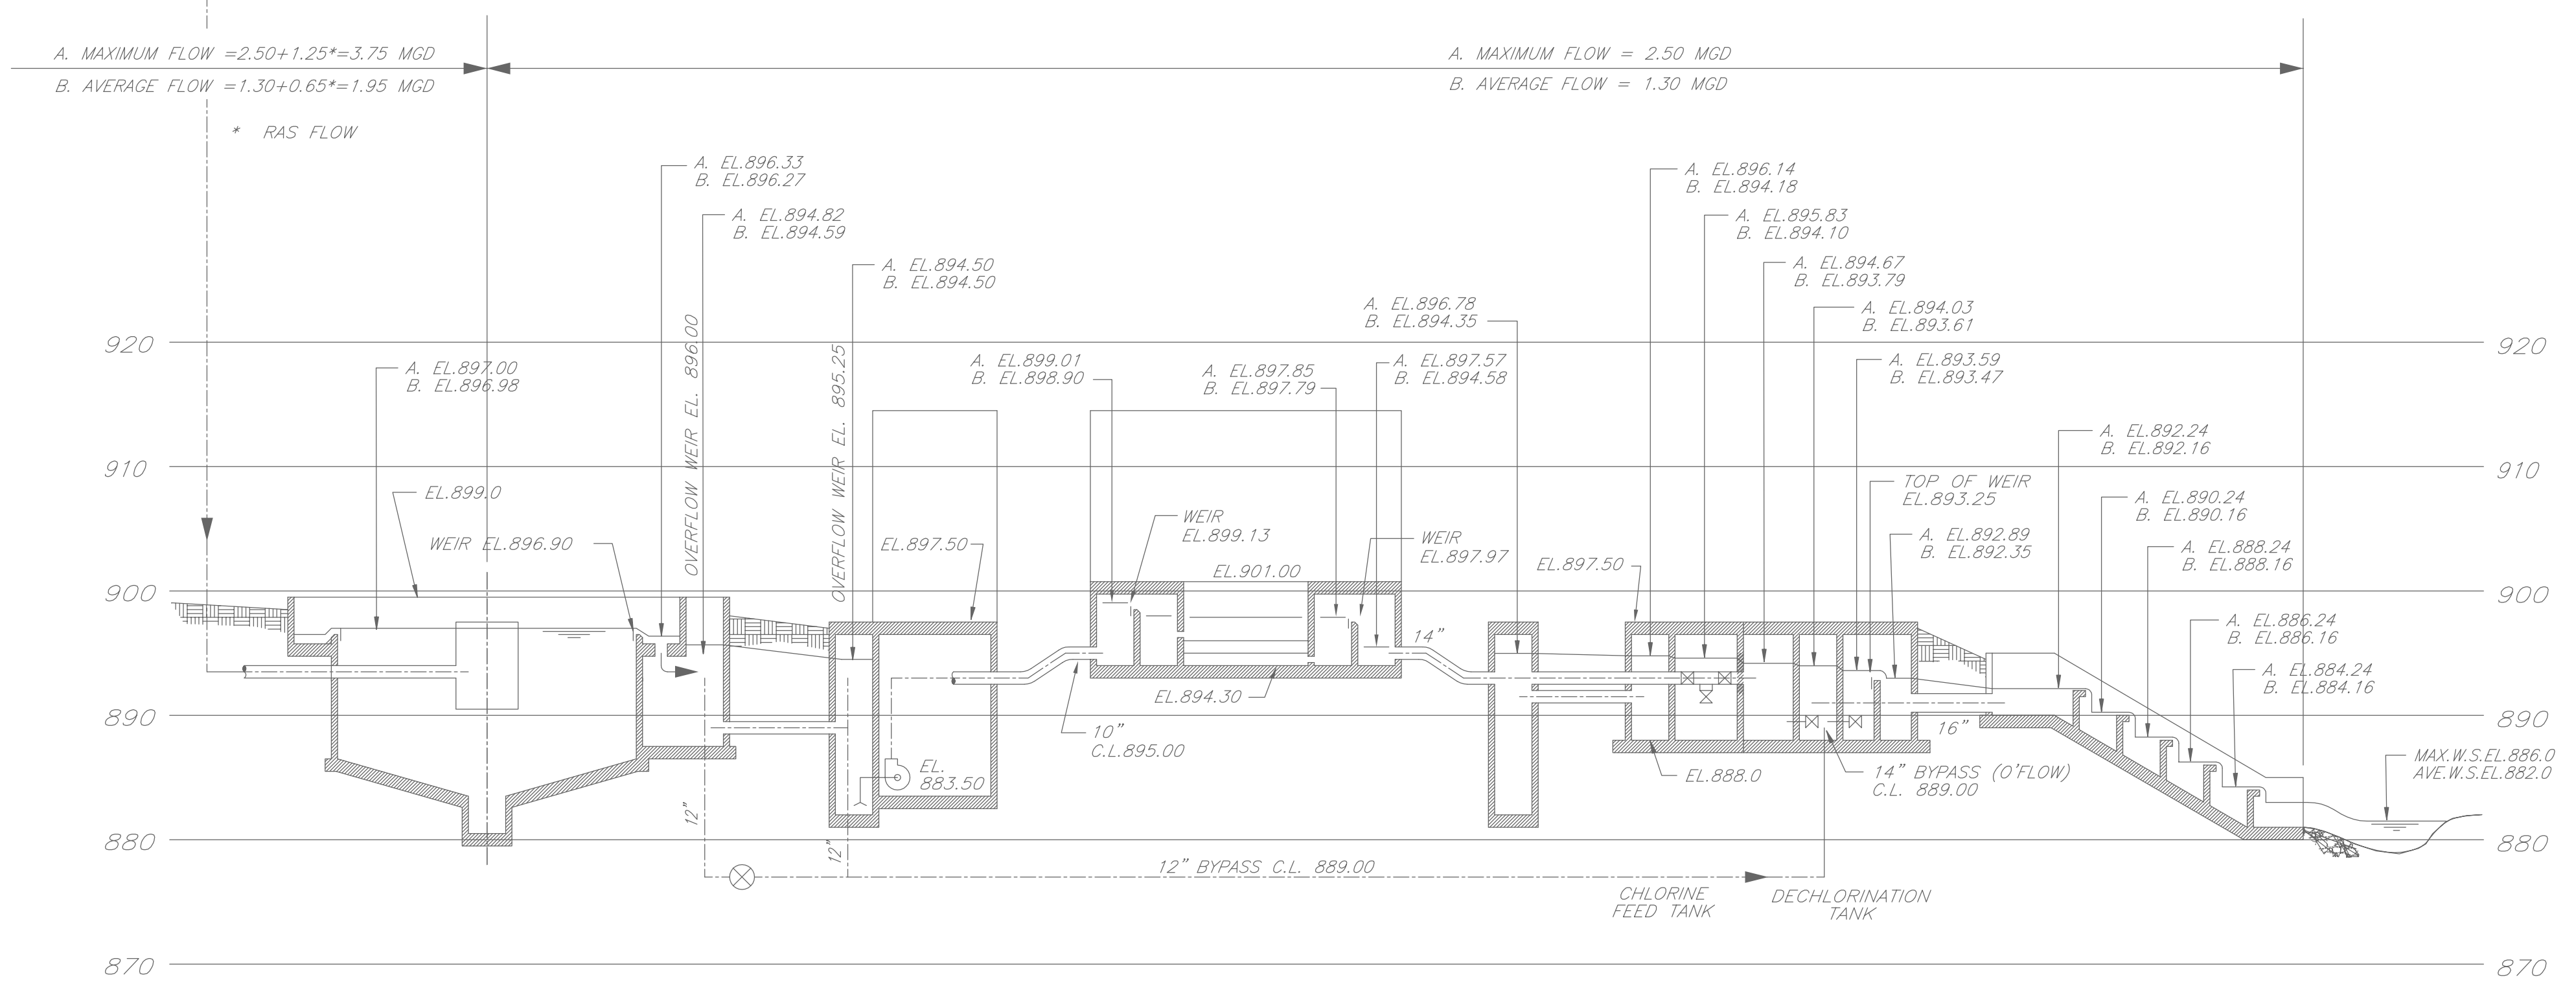

FINAL SETTLING TANKS    FILTER INFLUENT PUMPS    FILTER BUILDING    SFE WET WELL    CHLORINE CONTACT TANKS    CASCADES    HORSESHOE LAKE DRAIN

**HYDRAULIC PROFILE**  
 SCALE: 1" = 10'V, NONE H

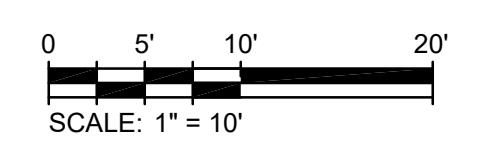

**TETRA TECH**  
 www.tetra-tech.com  
 710 AVIS DRIVE, SUITE 100  
 ANN ARBOR, MI, 48108  
 PHONE: 734.665.6000, FAX: 734.665.2570

BY	DATE	DESCRIPTION

NORTHFIELD TOWNSHIP, MICHIGAN  
 WASTEWATER TREATMENT PLANT  
 WET WEATHER STORAGE TANK  
**PROCESS HYDRAULIC PROFILE**

Project #: 200-12748-15003  
 Designed By: MAT  
 Drawn By:  
 Checked By:












12/31/2015 5:36:36 PM - C:\P200-12748-15003\CAD\SHEETFILES\SITE\YP.DWG - TEITSM, MARC

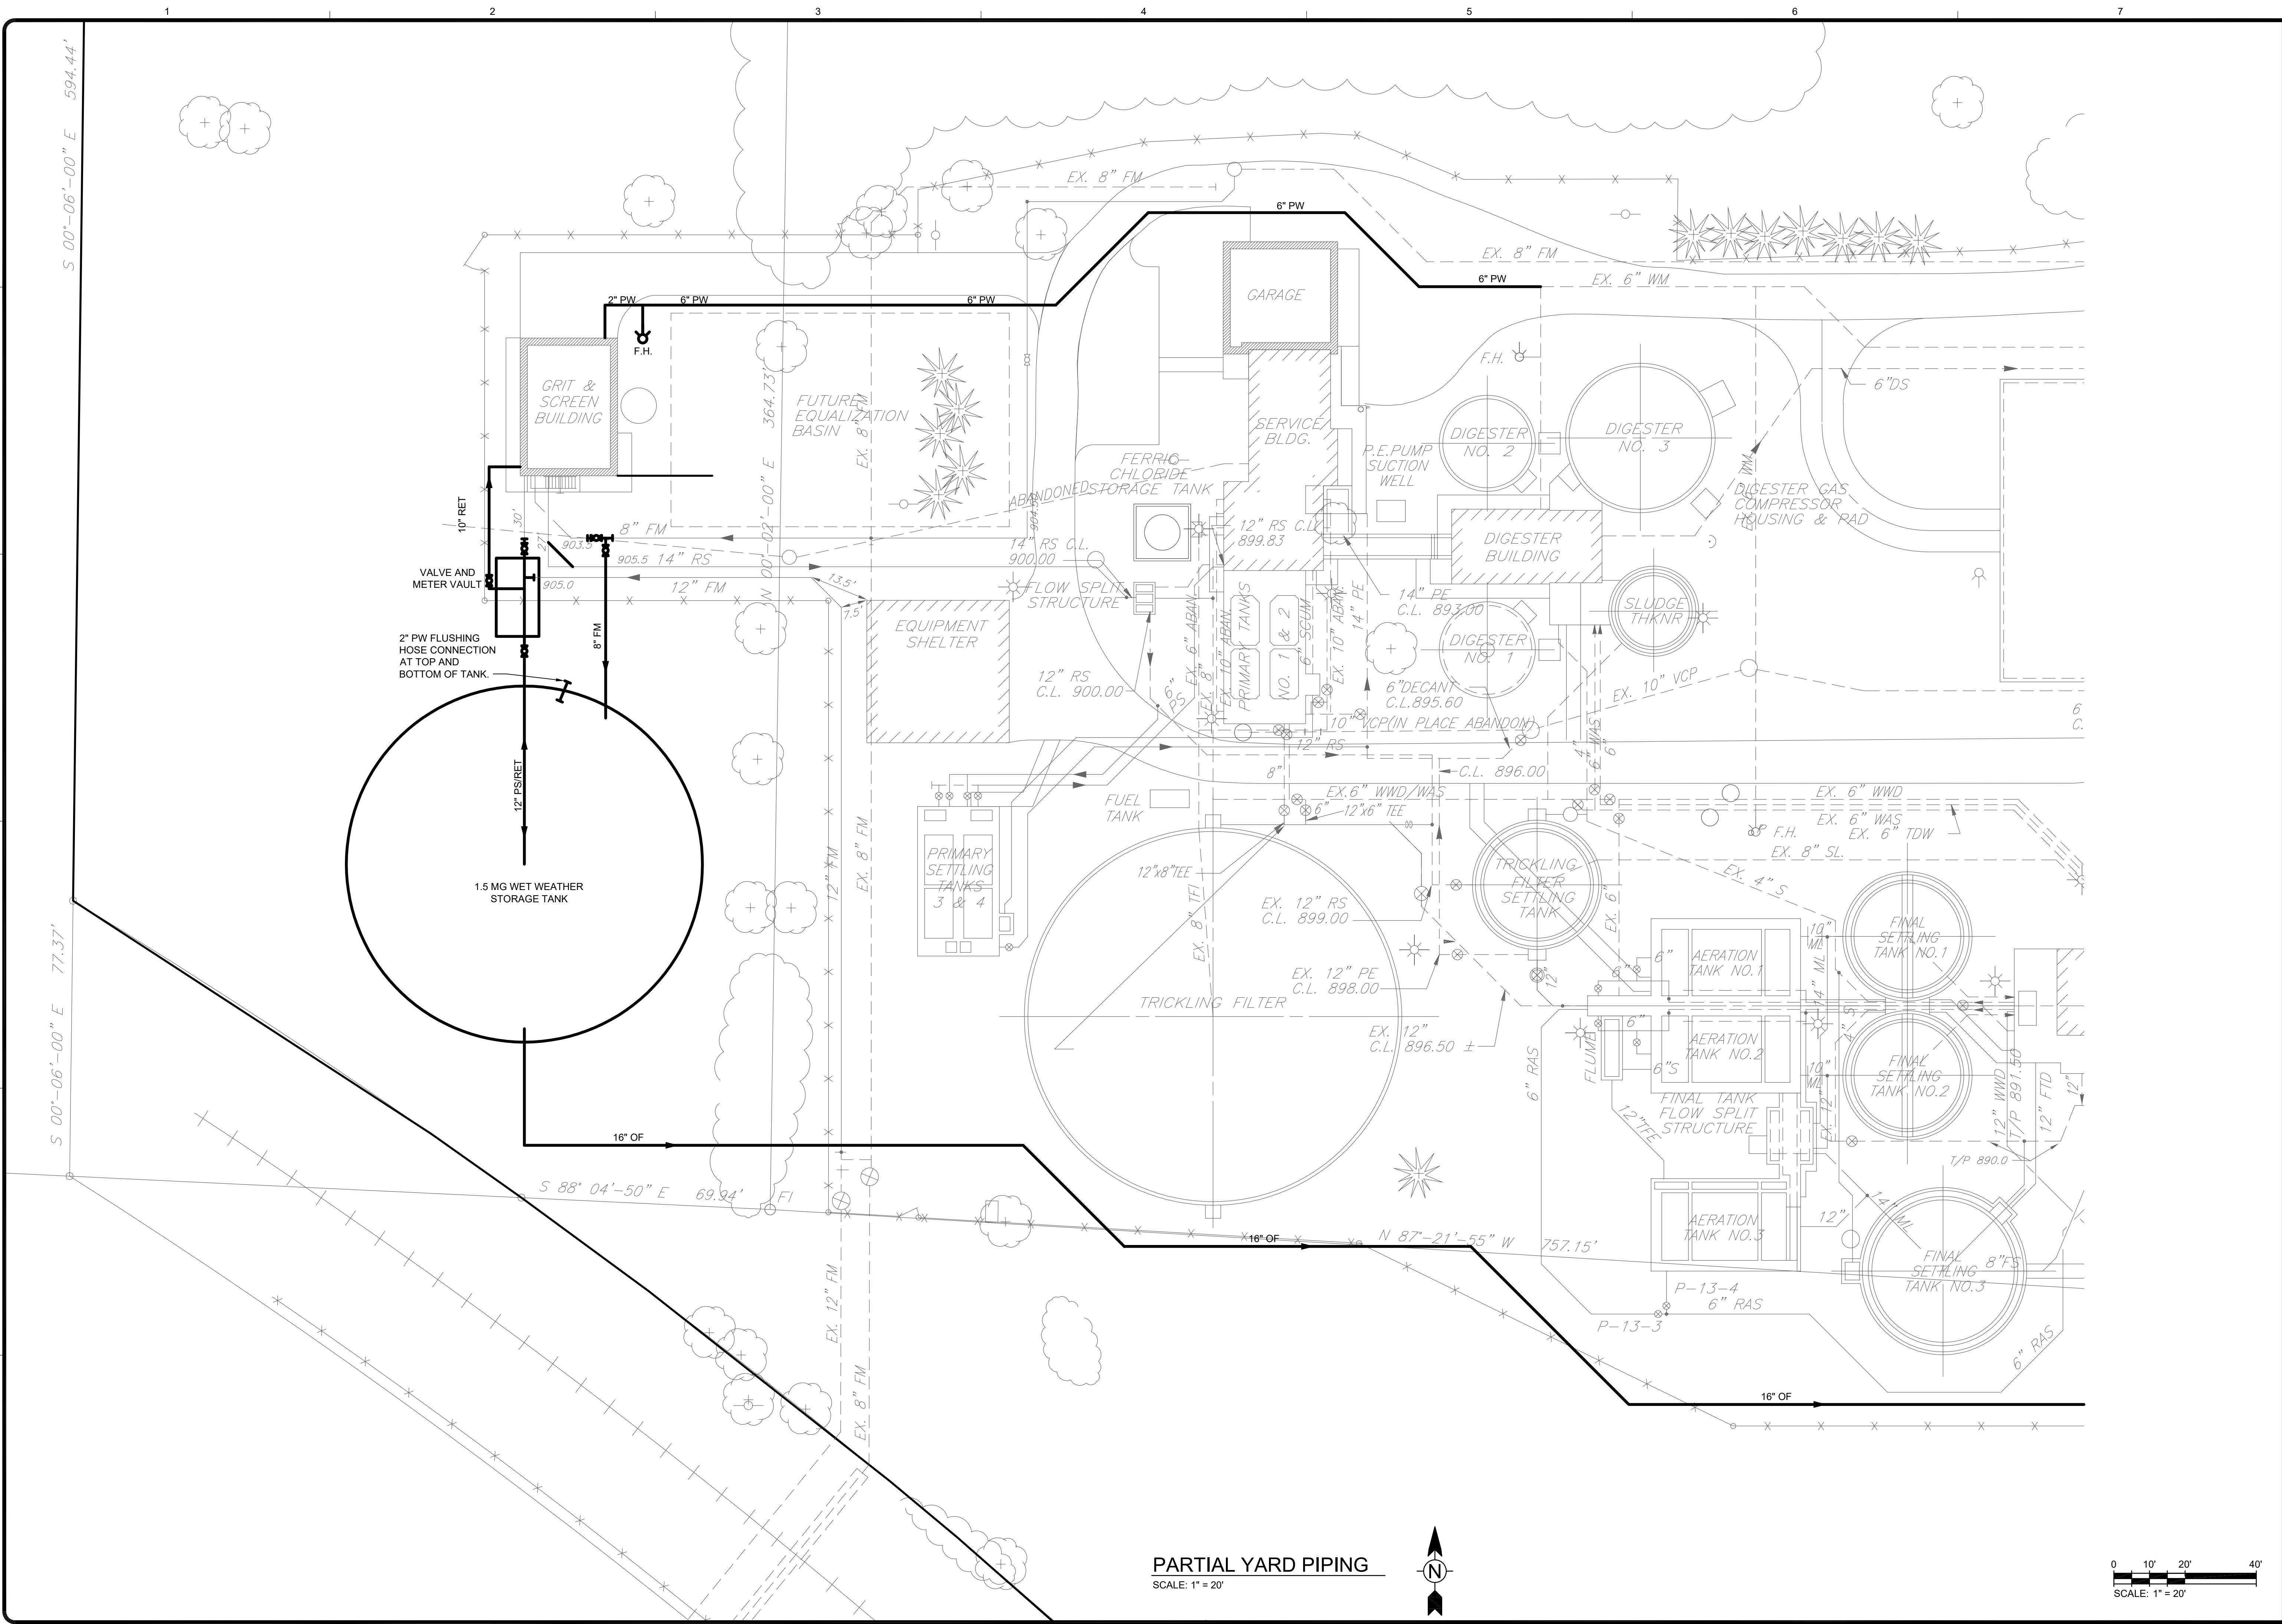

  **PARTIAL YARD PIPING**  
SCALE: 1" = 20'




MARK	DATE	DESCRIPTION



**NORTHFIELD TOWNSHIP, MICHIGAN**  
WASTEWATER TREATMENT PLANT  
WET WEATHER STORAGE TANK  
**PARTIAL YARD PIPING PLAN**

Project #:	200-12748-15003
Designed By:	MAT
Drawn By:	
Checked By:	

12/31/2015 5:37:32 PM - C:\P\200-12748-15003\CAD\SHEETFILES\SITE\YP.DWG - TEITSM, MARC

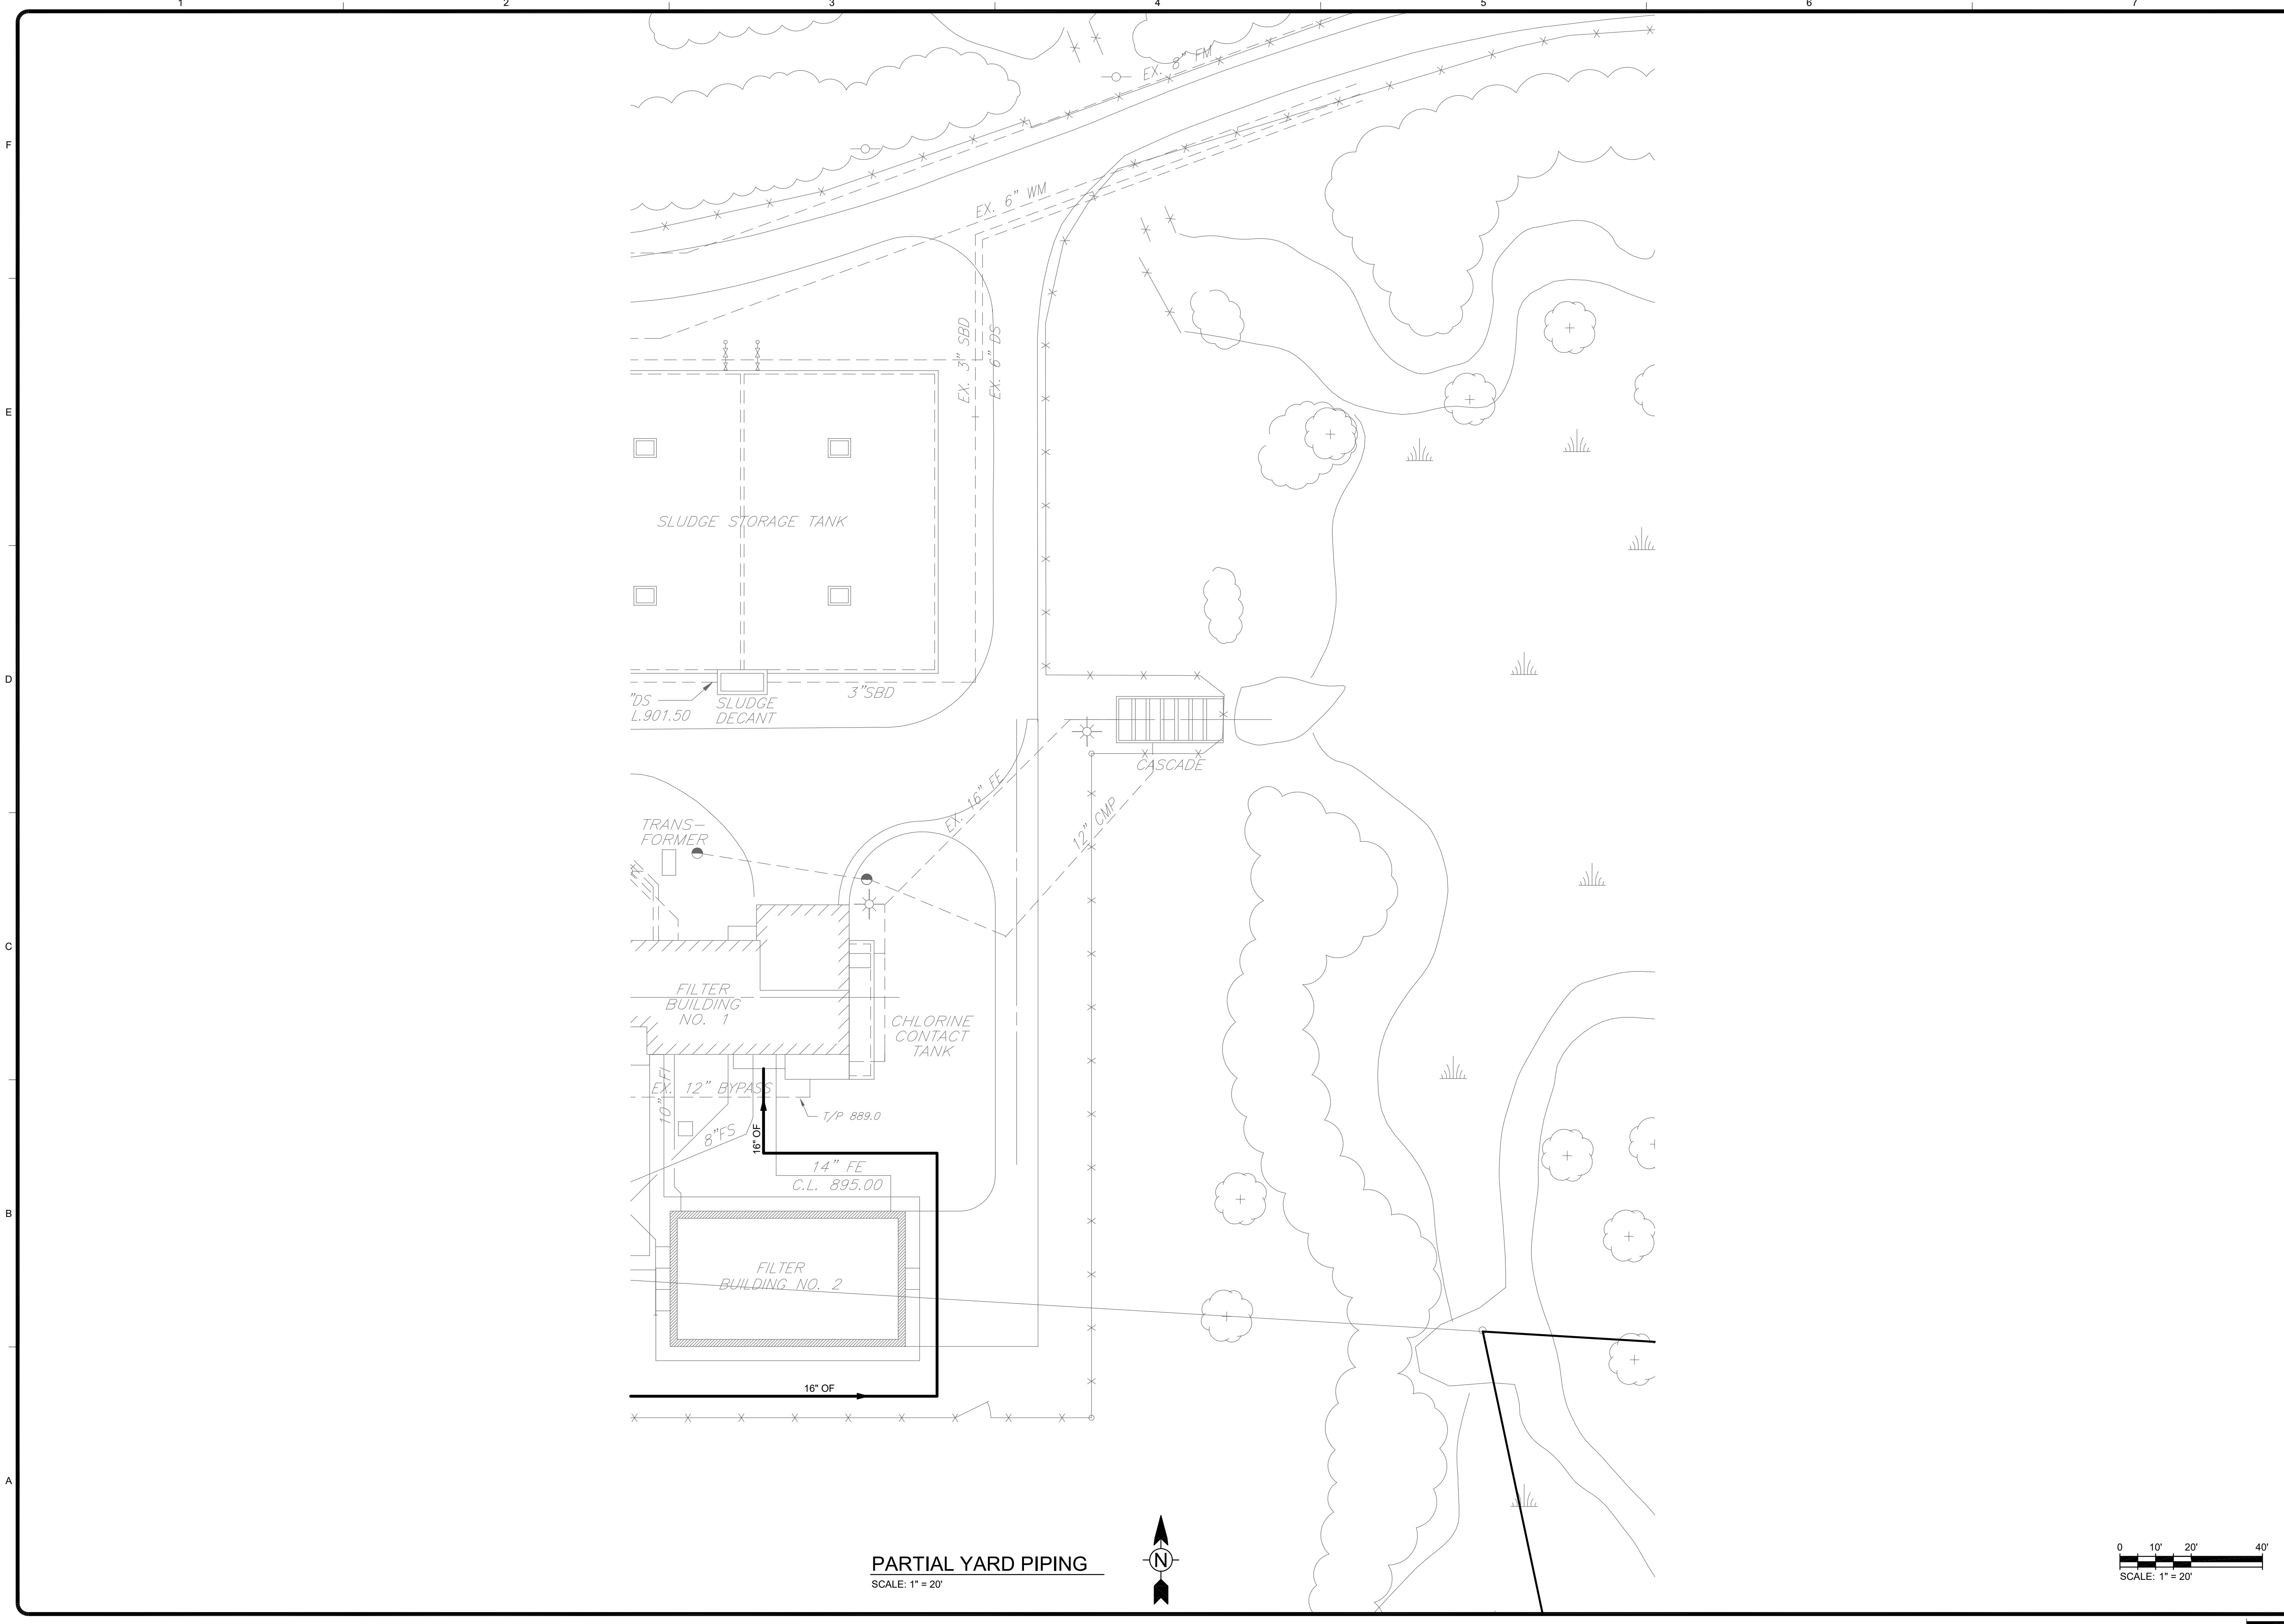

**PARTIAL YARD PIPING**  
 SCALE: 1" = 20'

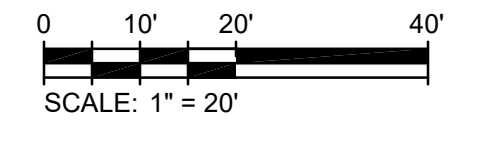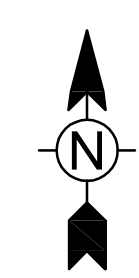

MARK	DATE	DESCRIPTION

**NORTHFIELD TOWNSHIP, MICHIGAN**  
**WASTEWATER TREATMENT PLANT**  
**WET WEATHER STORAGE TANK**  
**PARTIAL YARD PIPING PLAN**

Project #: 200-12748-15003  
 Designed By: MAT  
 Drawn By:  
 Checked By:

Copyright: Tetra Tech

Bar Measures 1 inch